


file name: 302102CR200\_Lots\_1-14.dwg, layout name: CR200, plotted by: Jesse Febrin, file location: G:\302102CR200\A\CAD\plot\_date: 11/07/2018 4:16 PM, Sheet: of: 1 Sheets

Rev	Amendments	Approved	Date
1	ADDITIONAL LOT SITE CUTS	JF	16-12-17
0	ISSUED FOR CONSTRUCTION	JF	28-06-17
A	ISSUED FOR TENDER	JF	23-04-17


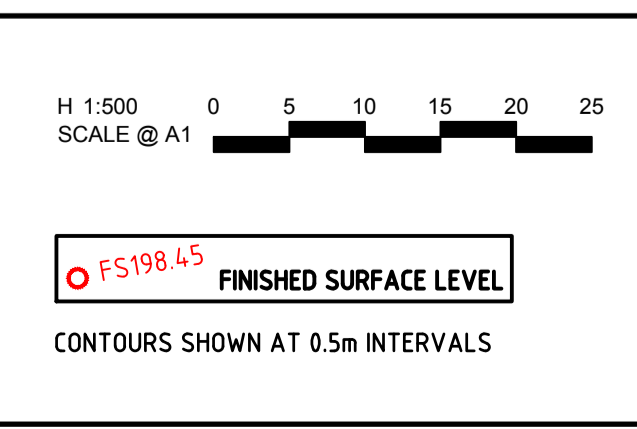


© Spiire Australia Pty Ltd All Rights Reserved  
 This document is produced by Spiire Australia Pty Ltd solely for the benefit of and use by the client in accordance with the terms of the retainer. Spiire Australia Pty Ltd does not and shall not assume any responsibility or liability whatsoever to any third party arising out of any use or reliance by third party on the content of this document.

16 Bridge Street Bendigo  
 Victoria 3550 Australia T 61 3 5448 2500  
 spiire.com.au ABN 55 050 029 635


Designed JF	Checked BI
Authorised JF	Date 11-01-18

**THE PERCH**  
**STAGE 2**  
**ROAD & DRAINAGE LAYOUT PLAN**  
 CITY OF GREATER BENDIGO  
 JLEJ INVESTMENTS PTY LTD  
**CONSTRUCTION** Drg No **302102CR200** Rev **1**

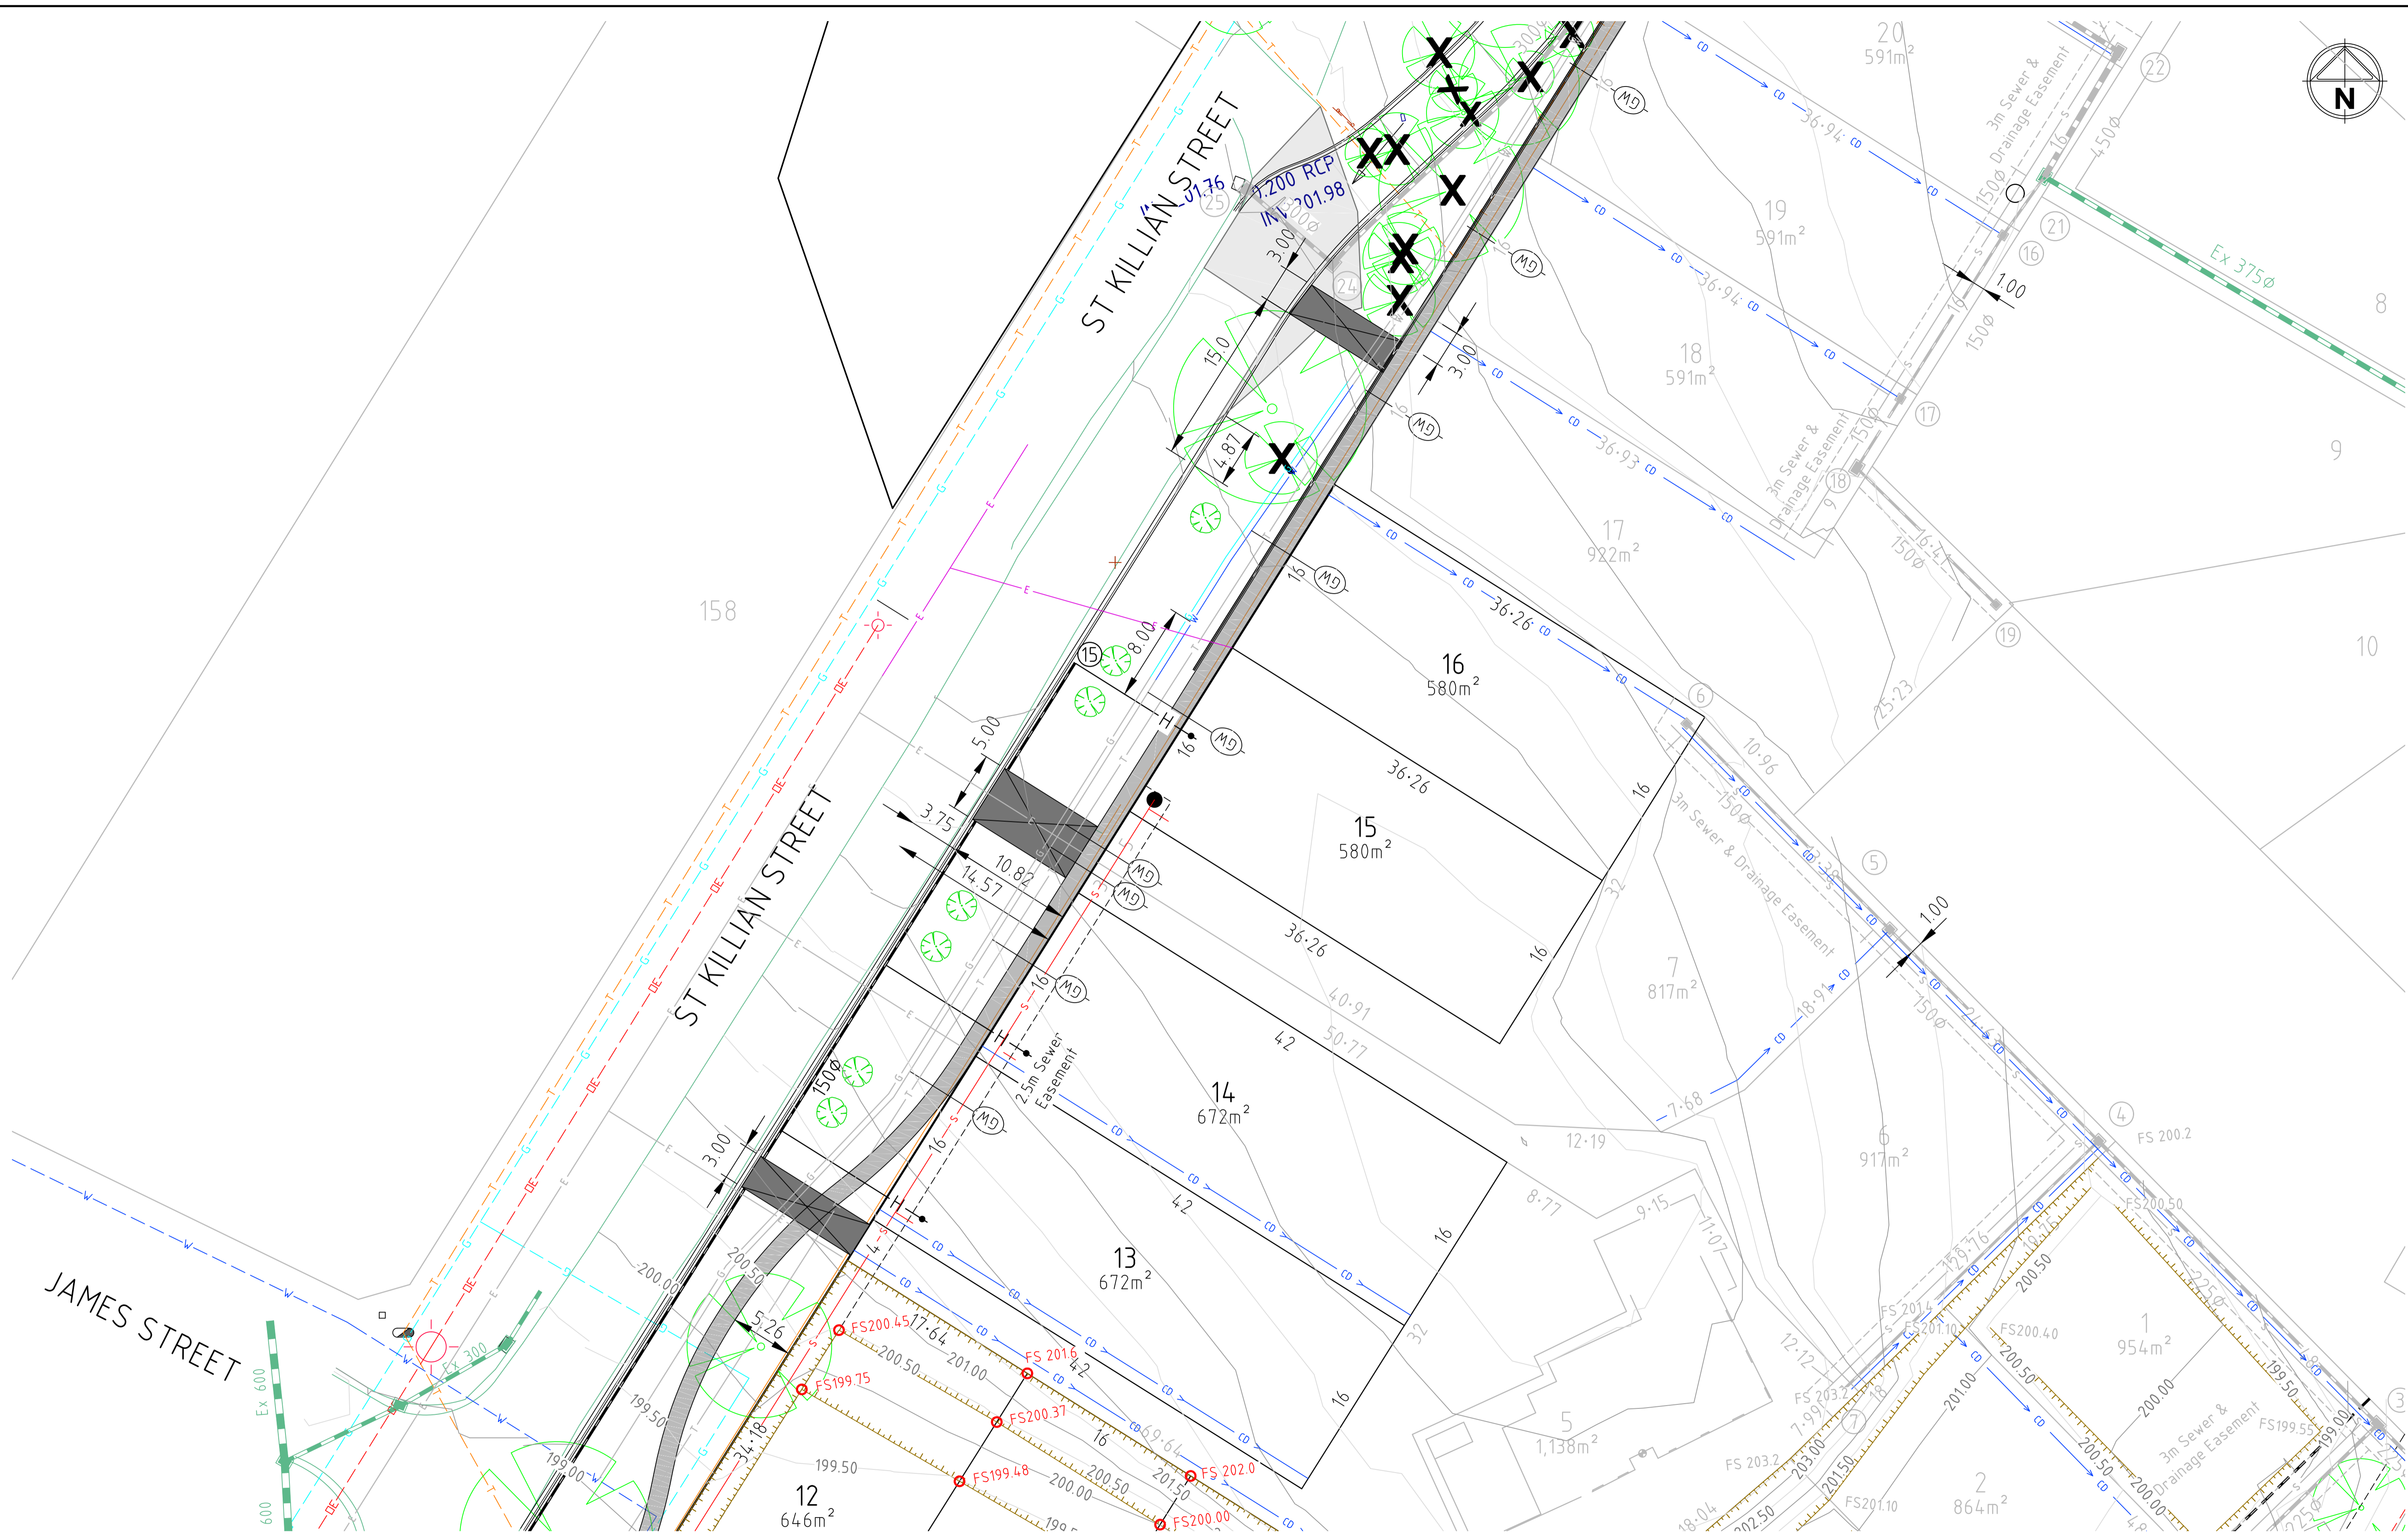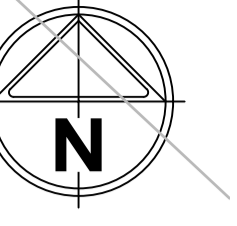

file name: 302102CR201\_Lots\_1-25.dwg, layout name: CR201, created by: Jesse Fehring  
 file location: G:\302102\302102\A\CAD\plot\_date: 11/07/2018 4:16 PM, Sheet: of: 5 Sheets

Rev	Amendments	Approved	Date
1	ADDITIONAL LOT SITE CUTS	JF	16-12-17
0	ISSUED FOR CONSTRUCTION	JF	28-06-17
A	ISSUED FOR TENDER	JF	23-04-17

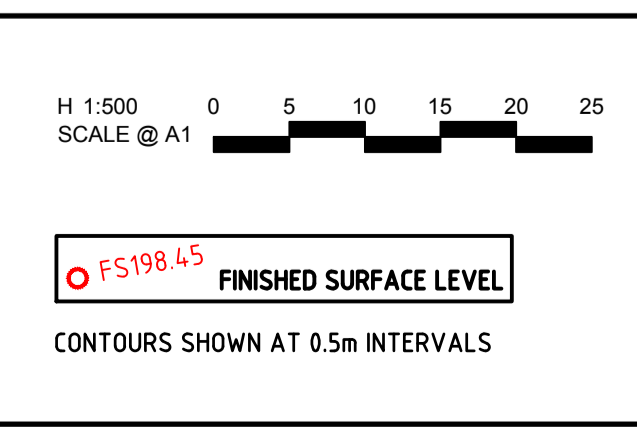

© Spiire Australia Pty Ltd All Rights Reserved  
 This document is produced by Spiire Australia Pty Ltd solely for the benefit of and use by the client in accordance with the terms of the retainer. Spiire Australia Pty Ltd does not and shall not assume any responsibility or liability whatsoever to any third party arising out of any use or reliance by third party on the content of this document.

16 Bridge Street Bendigo  
 Victoria 3550 Australia T 61 3 5448 2500  
 spiire.com.au ABN 55 050 029 635

Designed JF	Checked BI
Authorised JF	Date 11-01-18

**THE PERCH**  
**STAGE 2**  
**ROAD & DRAINAGE LAYOUT PLAN**  
 CITY OF GREATER BENDIGO  
 JLEJ INVESTMENTS PTY LTD  
**CONSTRUCTION** Drg No **302102CR201** Rev **1**